


SCALE 1" = 30'
0' 10' 20' 30' 60'

LEGEND
 EXISTING CONTOUR 760
 PROPOSED CONTOUR 760
 LOT GRADING DESIGNATION A, B or C
 DRAINAGE FLOW ARROW →

THE UTILITIES SHOWN ON THIS DRAWING ARE APPROXIMATE. ALL UTILITIES ARE TO BE FIELD VERIFIED BY CONTRACTOR. CONTRACTOR TO NOTIFY ENGINEER OF ANY DISCREPANCIES. THRUST BLOCKS AT ALL BENDS. CONTRACTOR is to call Texas One Call TOLL FREE: 1-800-245-4545 prior to any excavation for underground utility location. APWA STANDARD. Color code for temporary marking of underground facilities: RED = Electric powerlines, cables, conduit, and lighting cables; YELLOW = Gas, oil, steam, petroleum, or gaseous material; ORANGE = Communication, alarm, or signal lines, cables, or conduit; BLUE = Potable water; GREEN = Sewer and drain lines; PURPLE = Recirculated water, irrigation, and slurry; PINK = Temporary survey markings; WHITE = Proposed excavation.

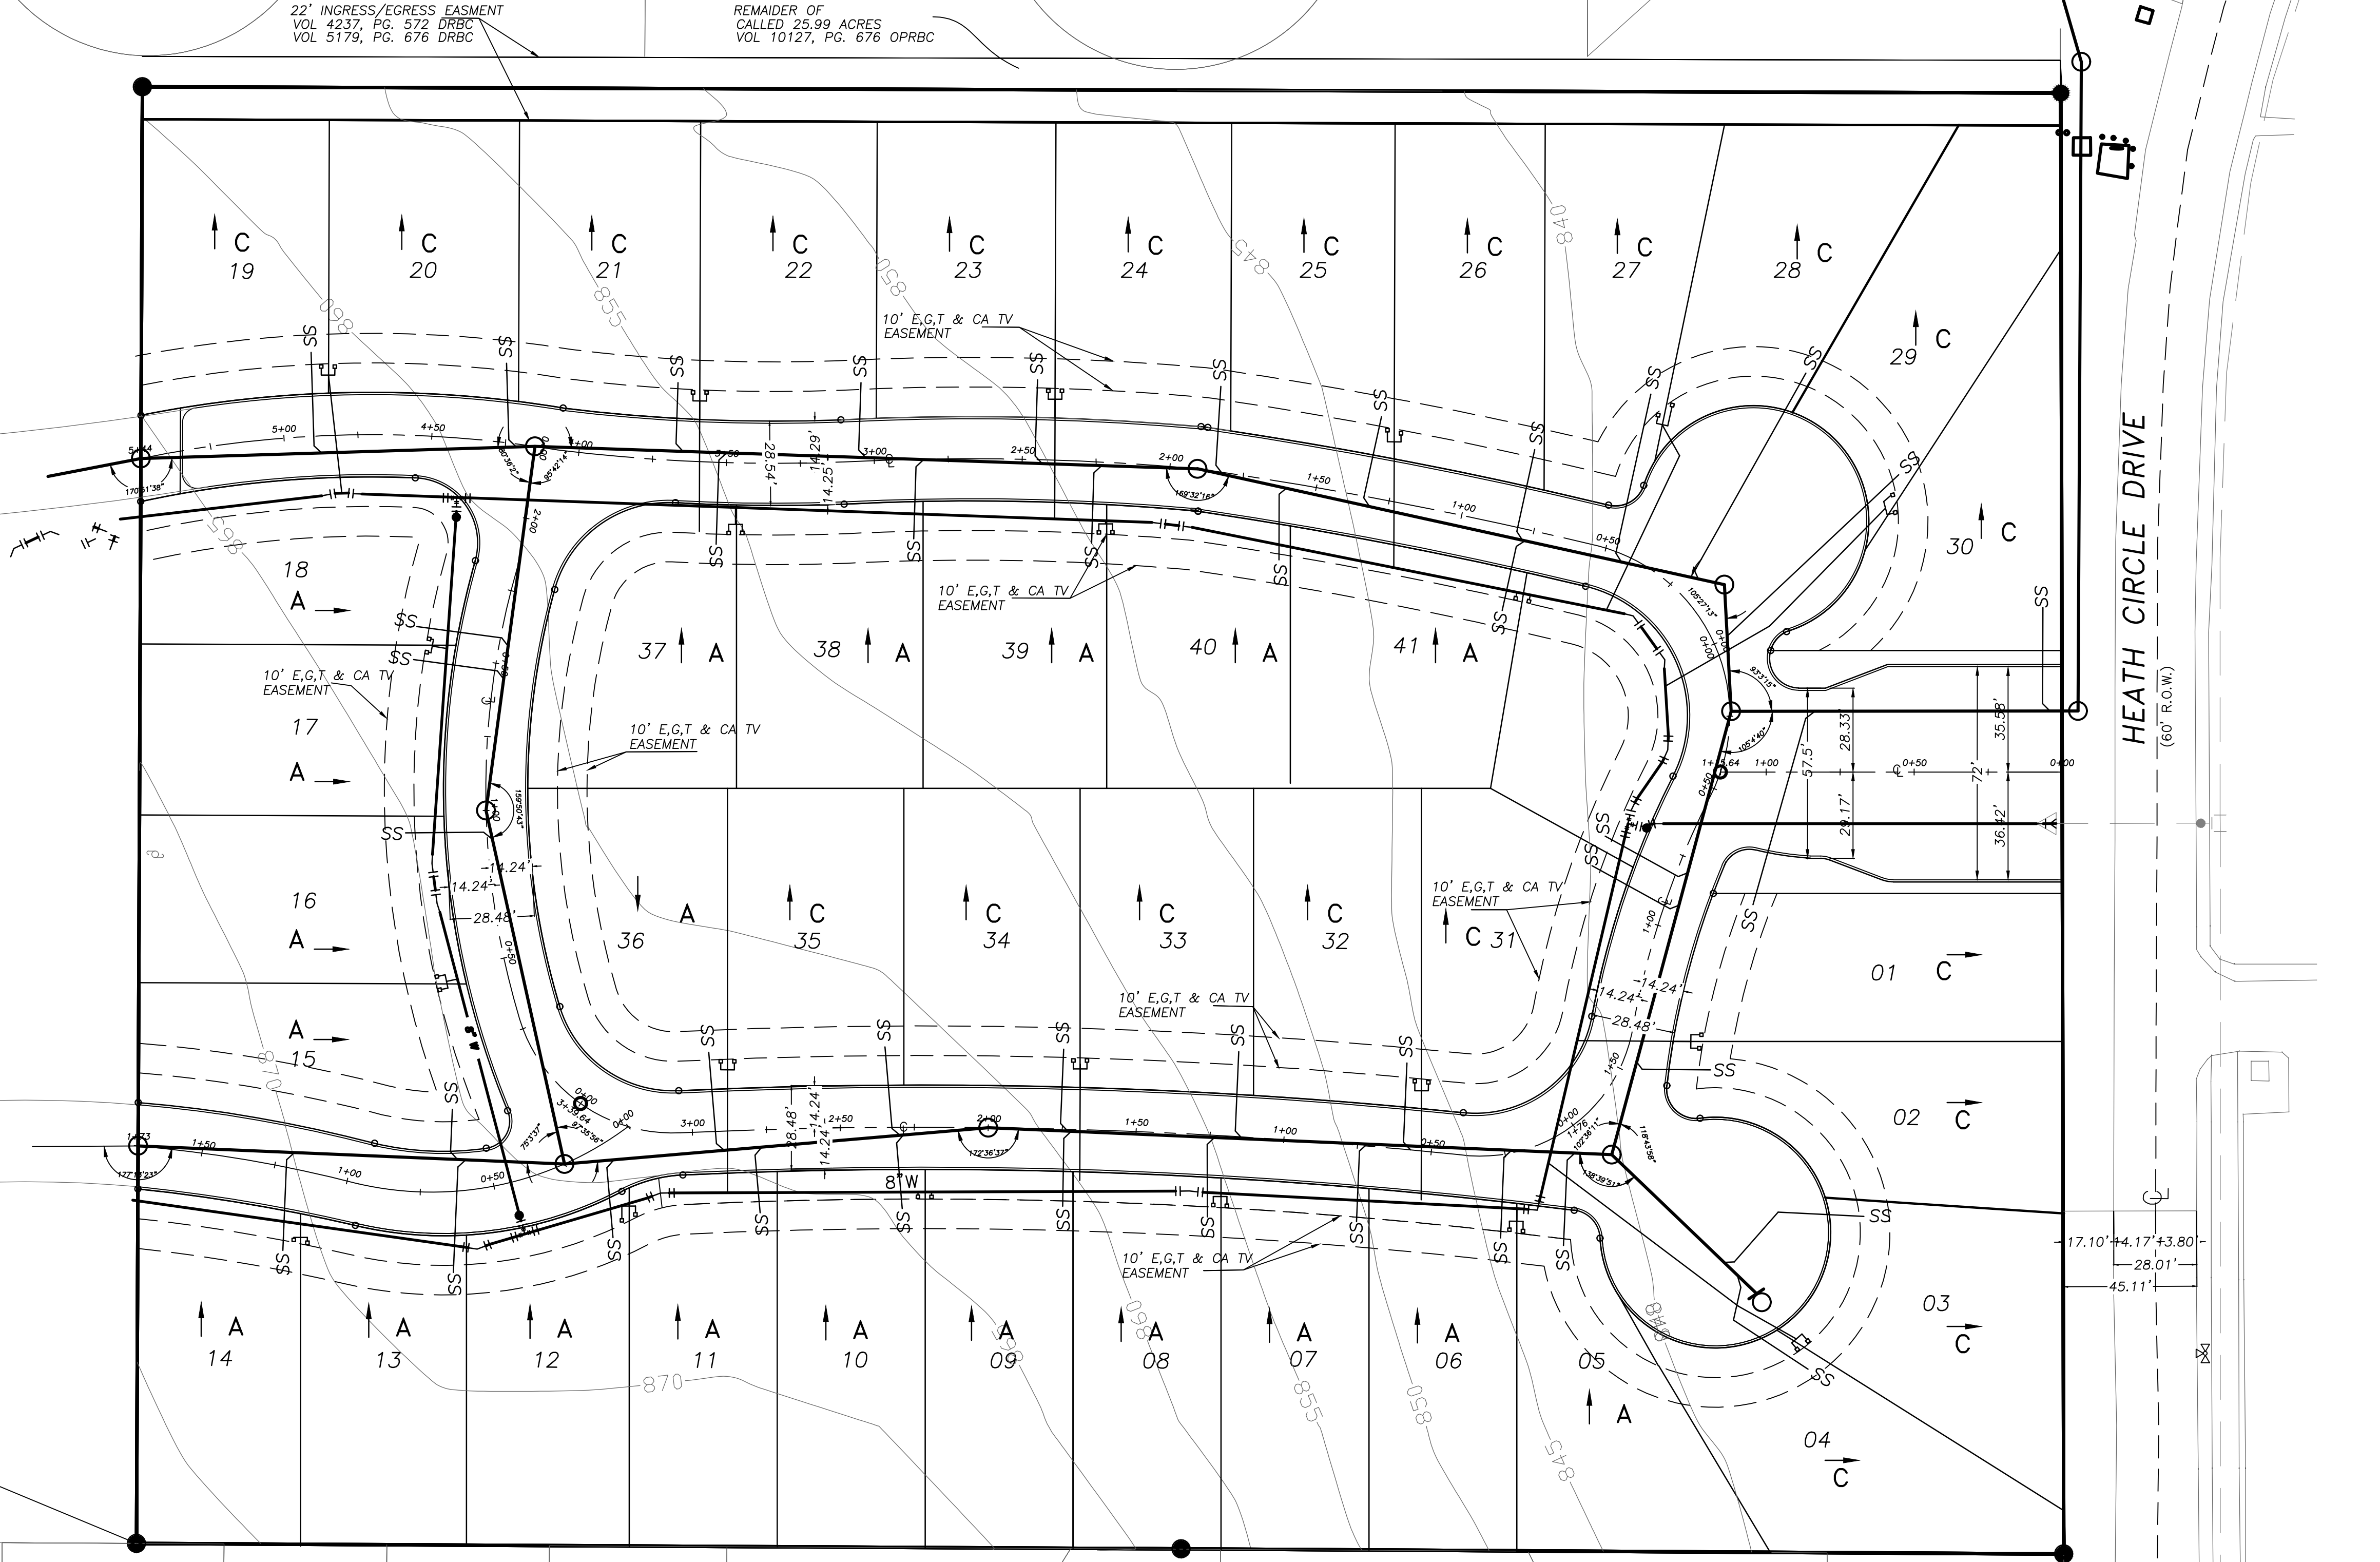

REVISIONS:	DESCRIPTION:
NO. DATE	

GGA
GOMEZ-GARCIA & ASSOCIATES, INC.
 19230 STONE OAK PARKWAY, SUITE 302, SAN ANTONIO, TEXAS 78258
 (210) 832-9608 - (210) 832-9615 FAX
 TBPB FIRM REGISTRATION #5362

HERON VALLEY
 GRADING PLAN

DESIGN	AG
DRAWN	JT
CHECKED	AG
DATE	AGO 2022
JOB NO.	378.001
SHEET	5
	5 OF 1

Path: Aug 26, 2022, 1:19pm, User: D. USEP
 File: C:\Users\USEP\Desktop\USA_220801\220825_DWG File of plot 4-24-22 (1) (2) (1).dwg